


LEGEND

- NEW TILE FLOOR
- NEW WOOD FLOORING
- NEW PLUMBING FIXTURES
- NEW EXTERIOR TILE FLOOR
- NEW CABINETS AND COUNTERTOPS

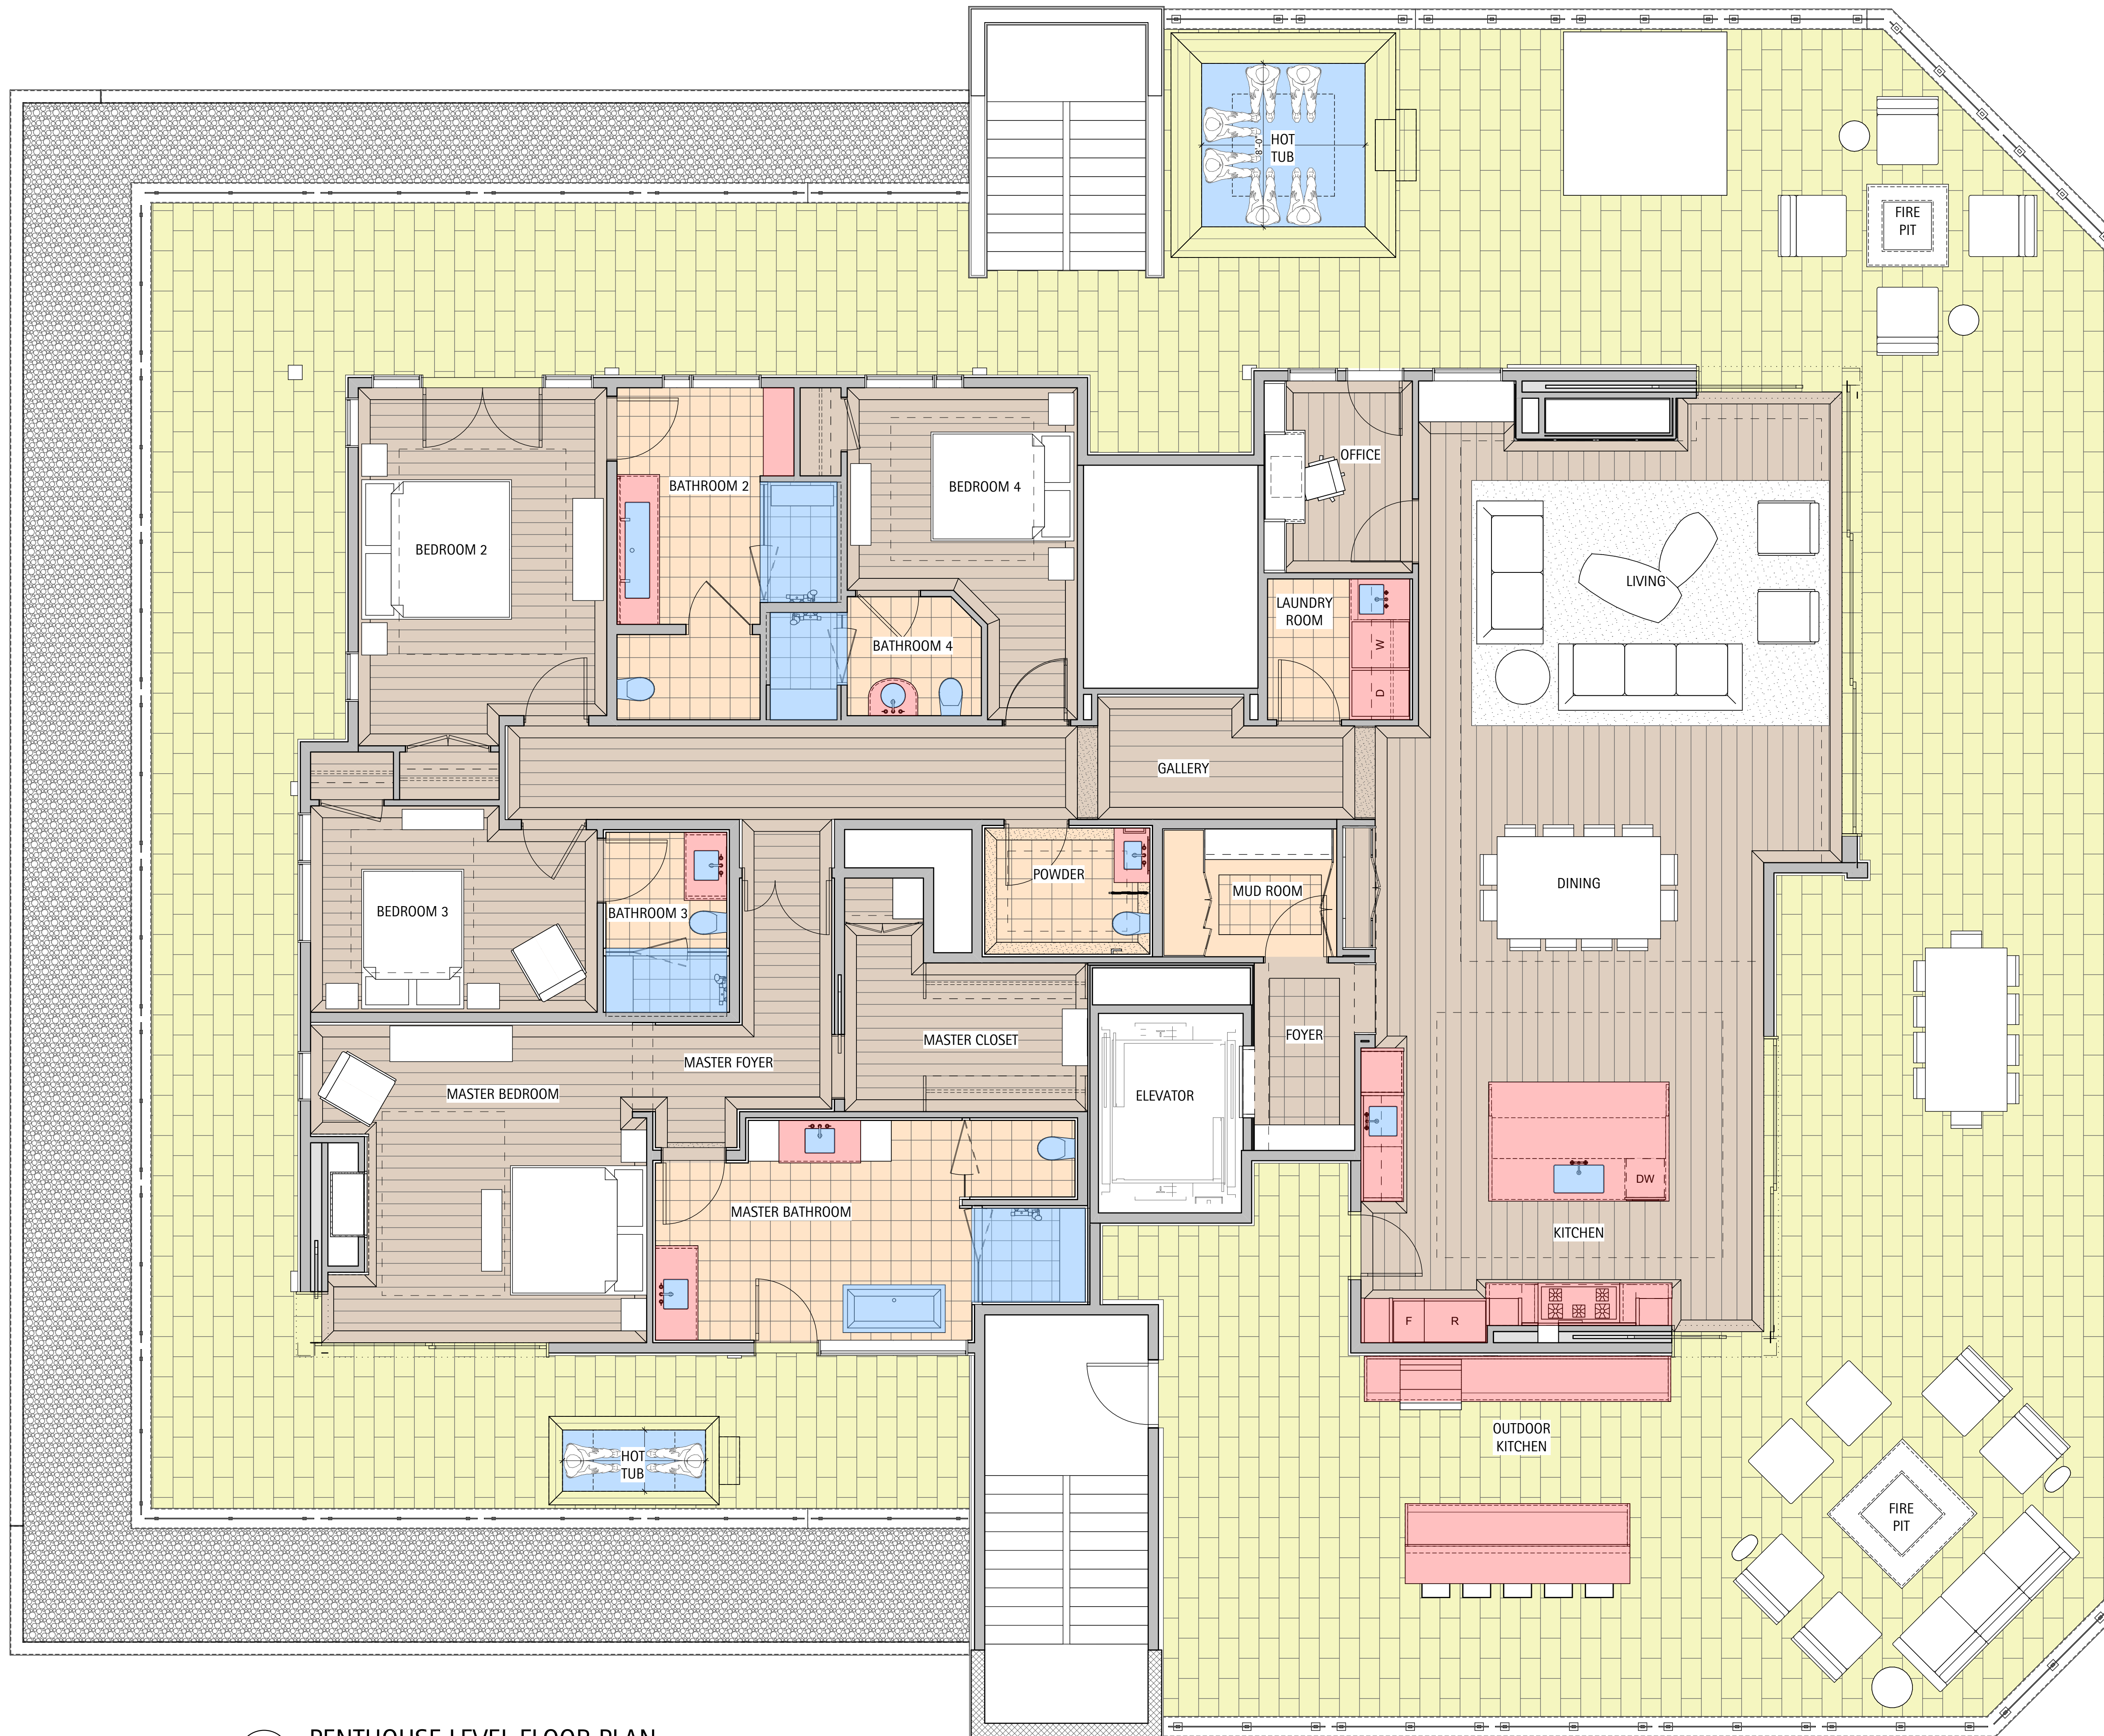

PENTHOUSE LEVEL FLOOR PLAN
 SCALE: 1/4" = 1'-0"

All Rights Reserved. This document is the property of David Johnston Architects PC. It is not to be used, copied, or distributed without the written consent of David Johnston Architects PC.